



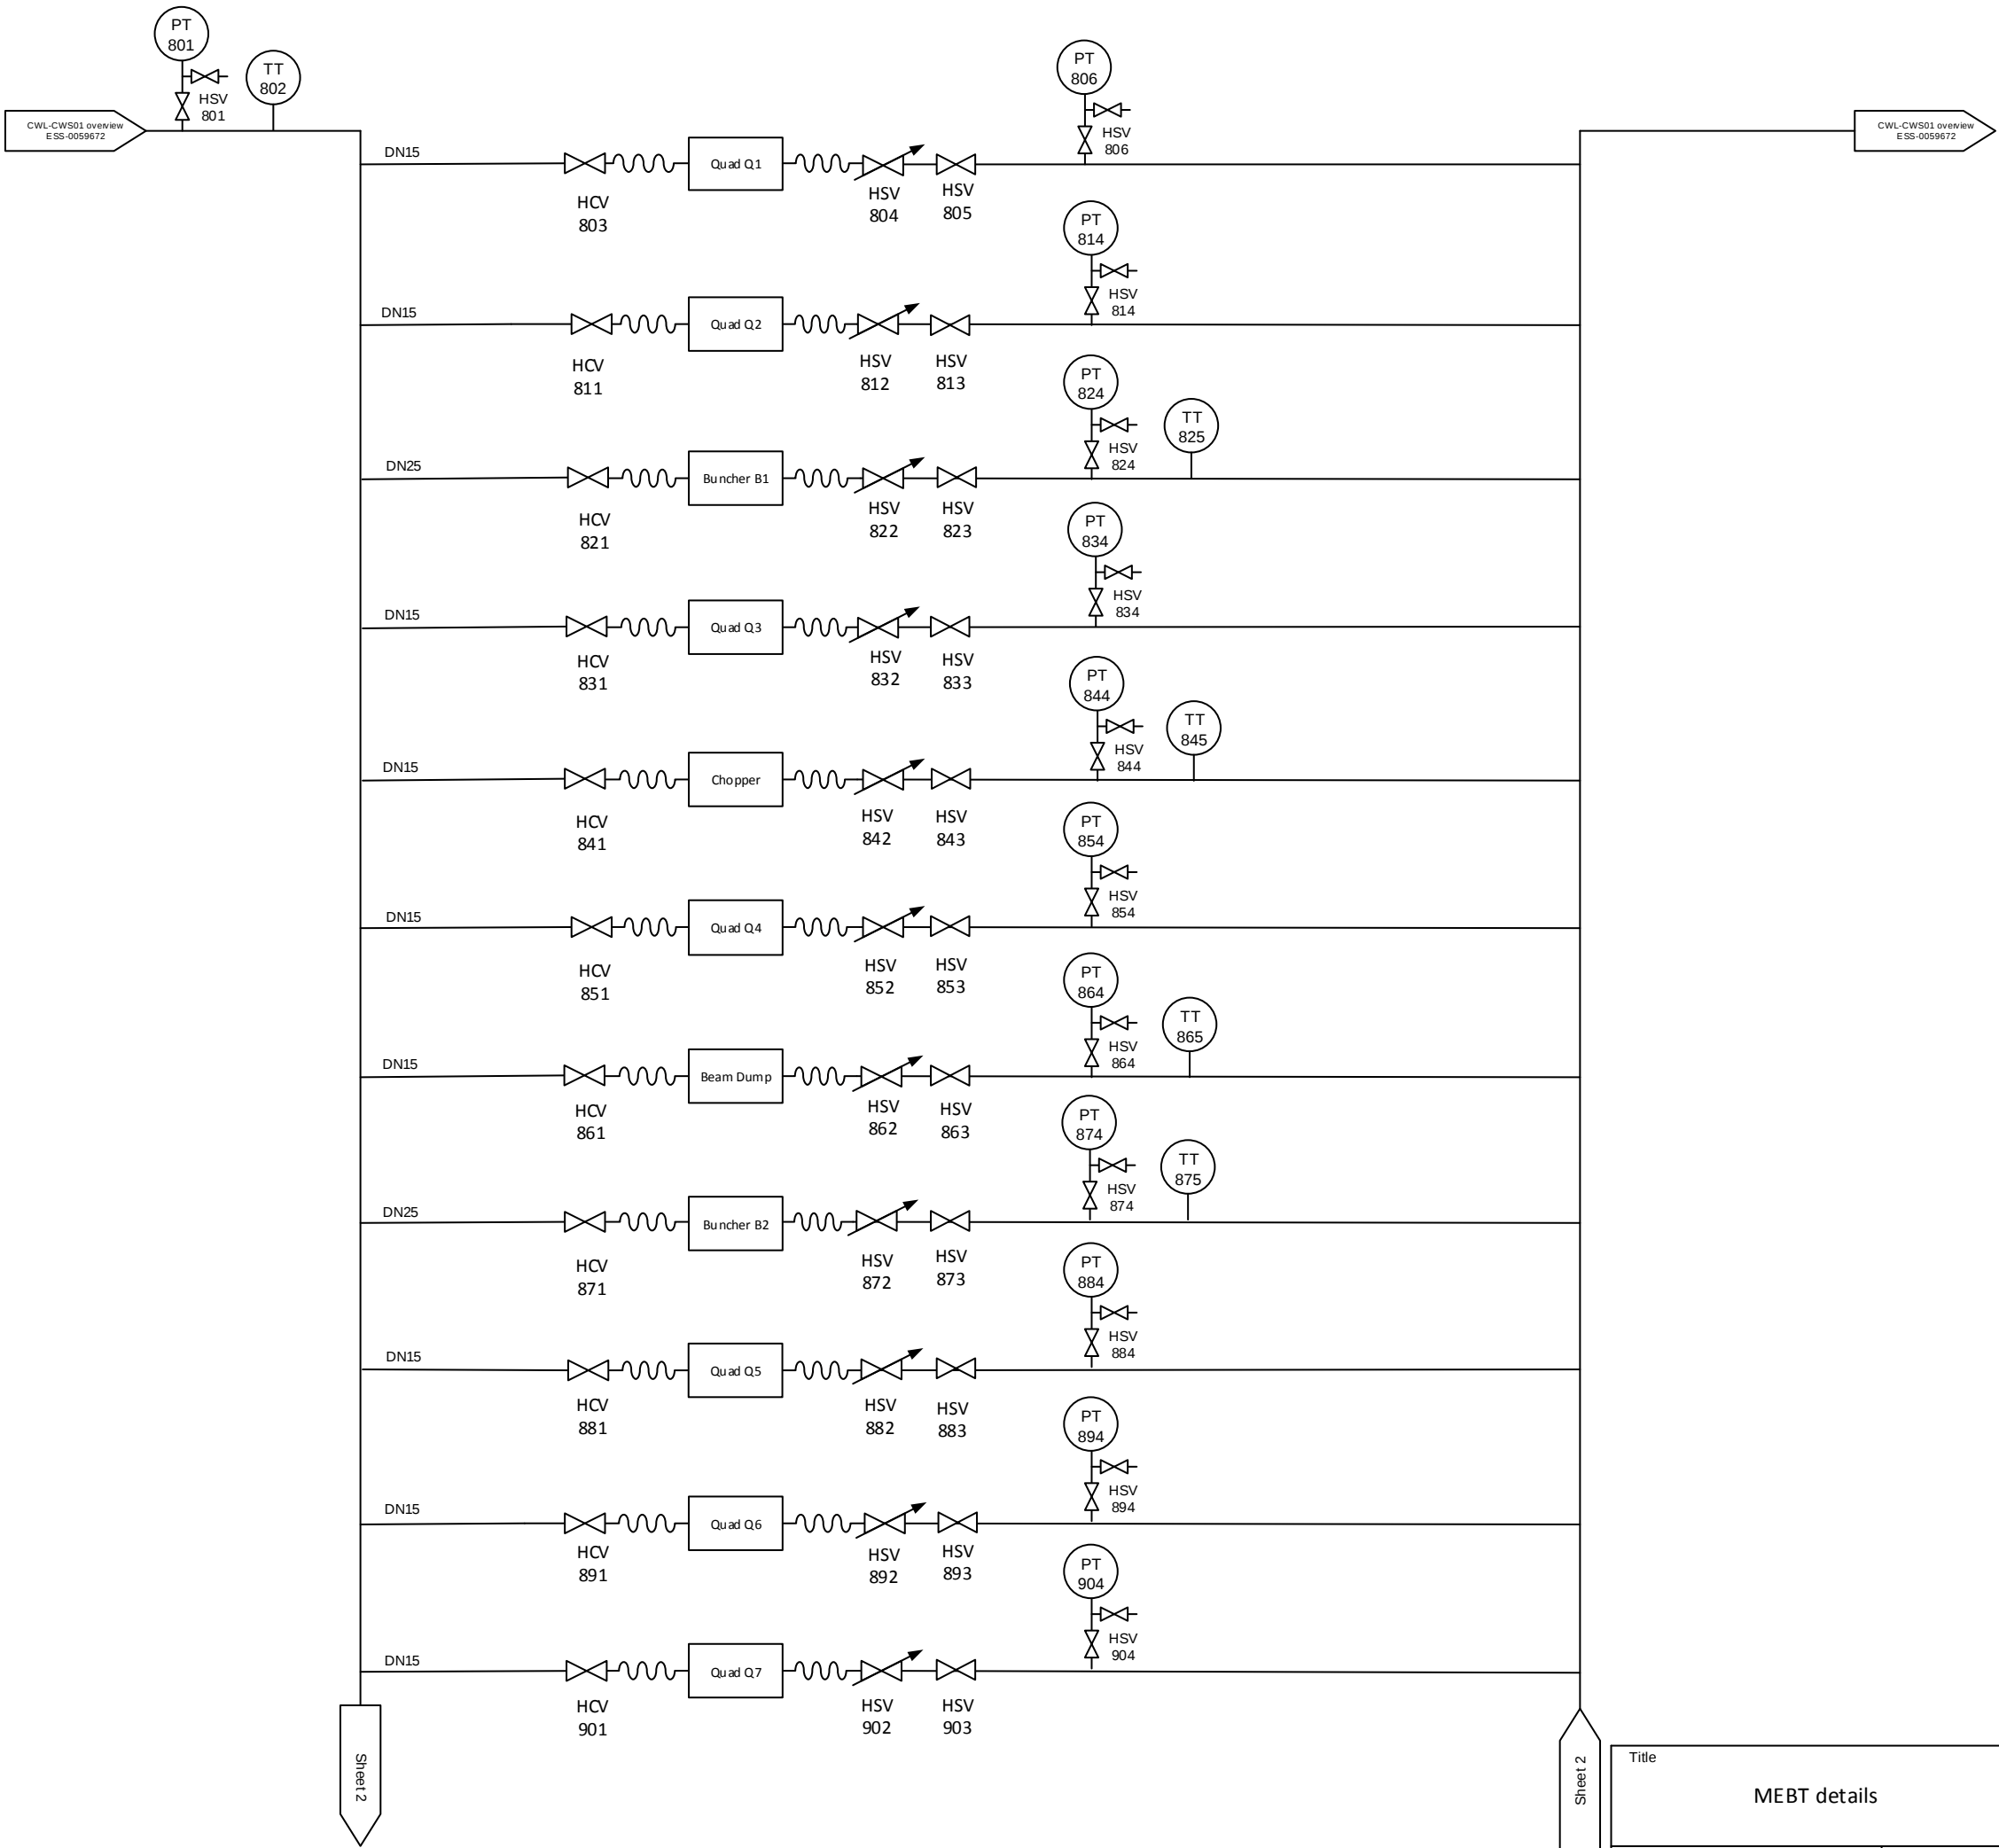

For Legend see ESS-0033888

Title MEBT details		Approved by -		Signature	 EUROPEAN SPALLATION SOURCE
		Designed / changed by AC		Signature	
Type of drawing P&ID	Date (this version) 2016/10/01	Size A3	Page 1 of 2	Scale -	Drawing No ESS-0059662
				Revision 1	

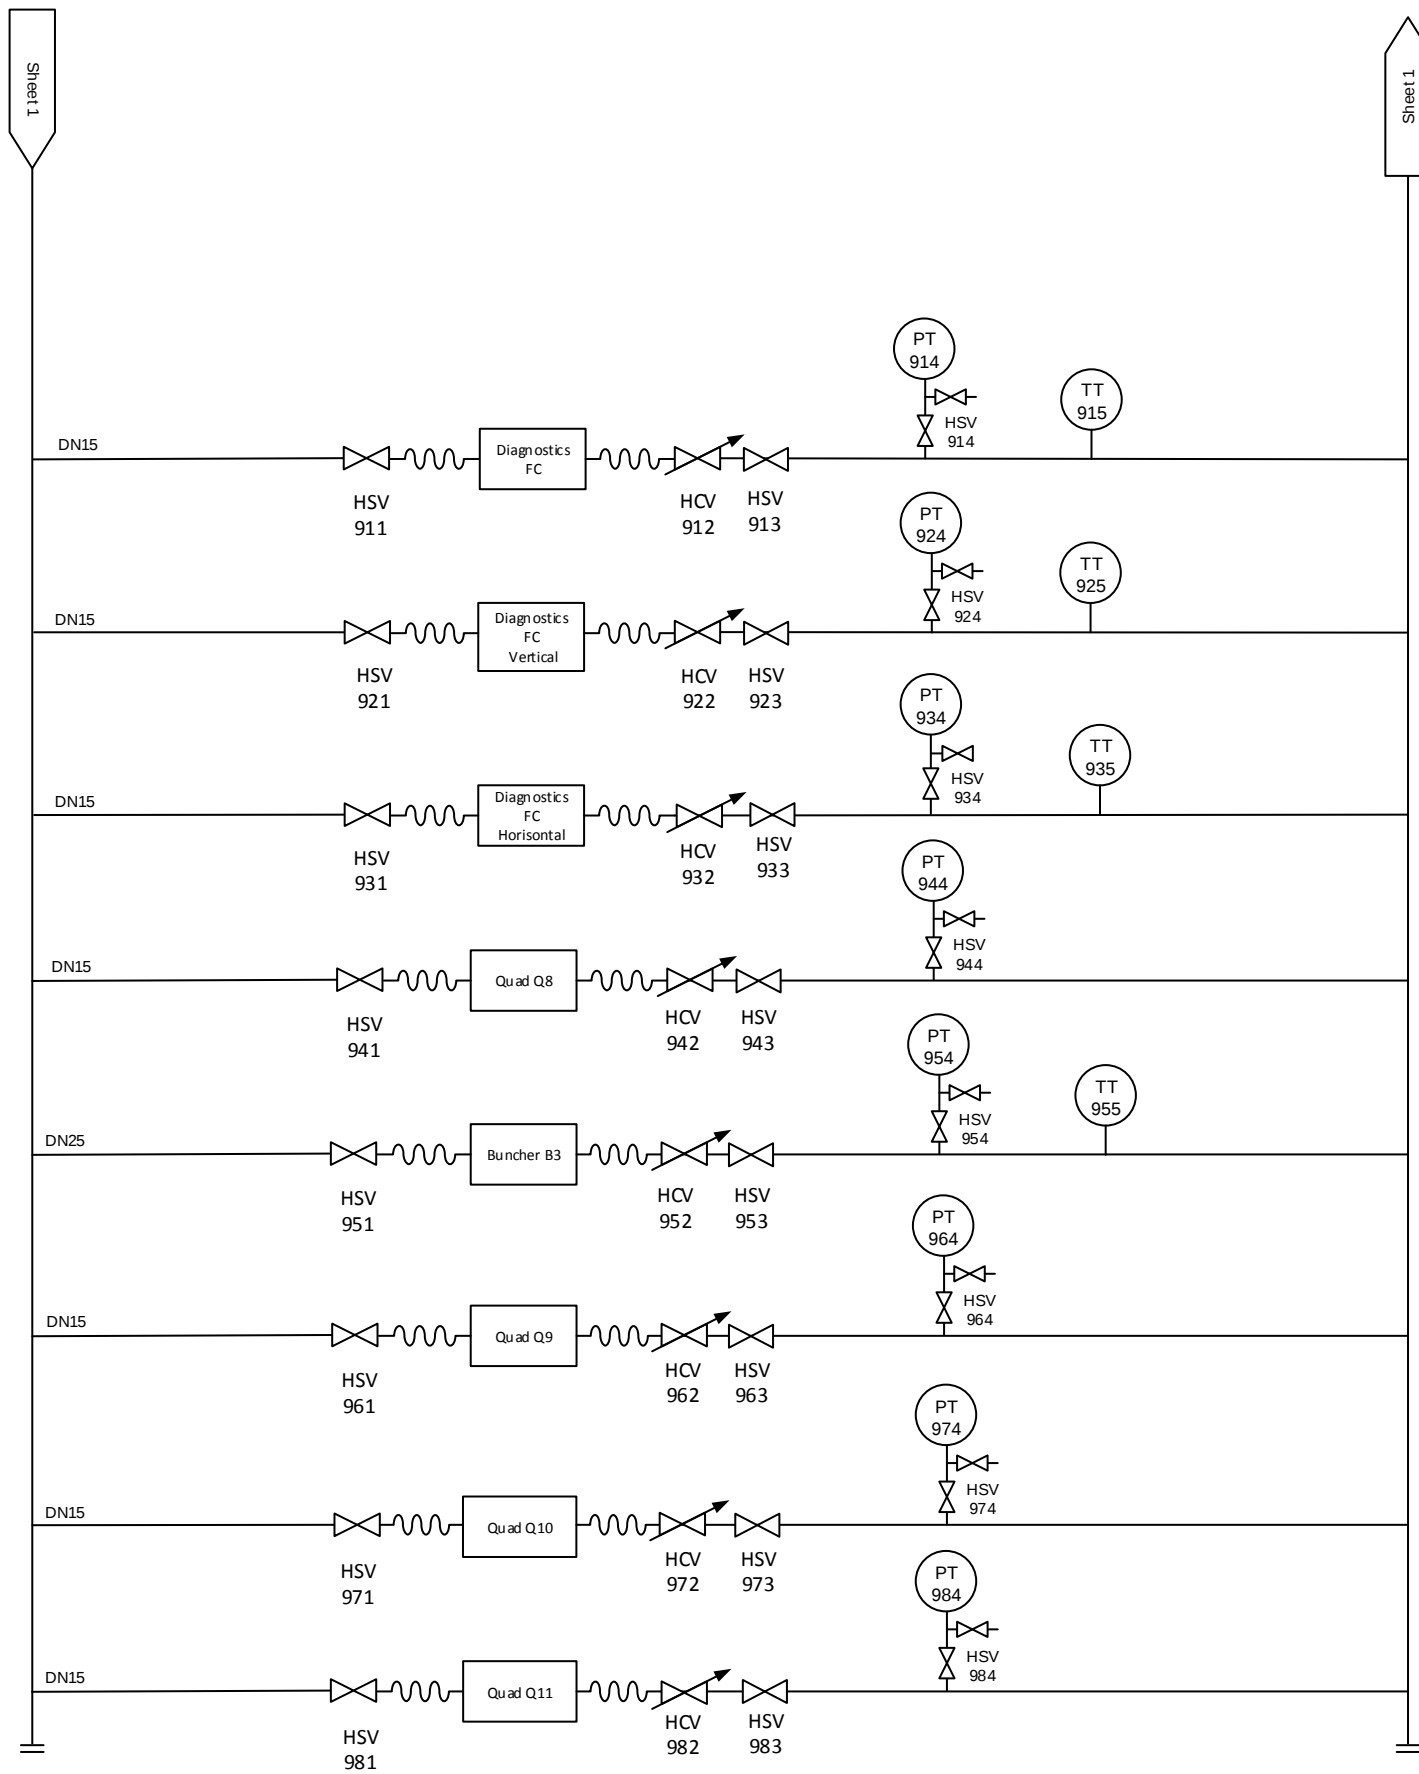

For Legend see ESS-0033888

Title MEBT details		Approved by -		Signature	
		Designed / changed by AC		Signature	
Type of drawing P&ID	Date (this version) 2016/10/01	Size A3	Page 2 of 2	Scale -	Drawing No ESS-0059662 Revision 1

