


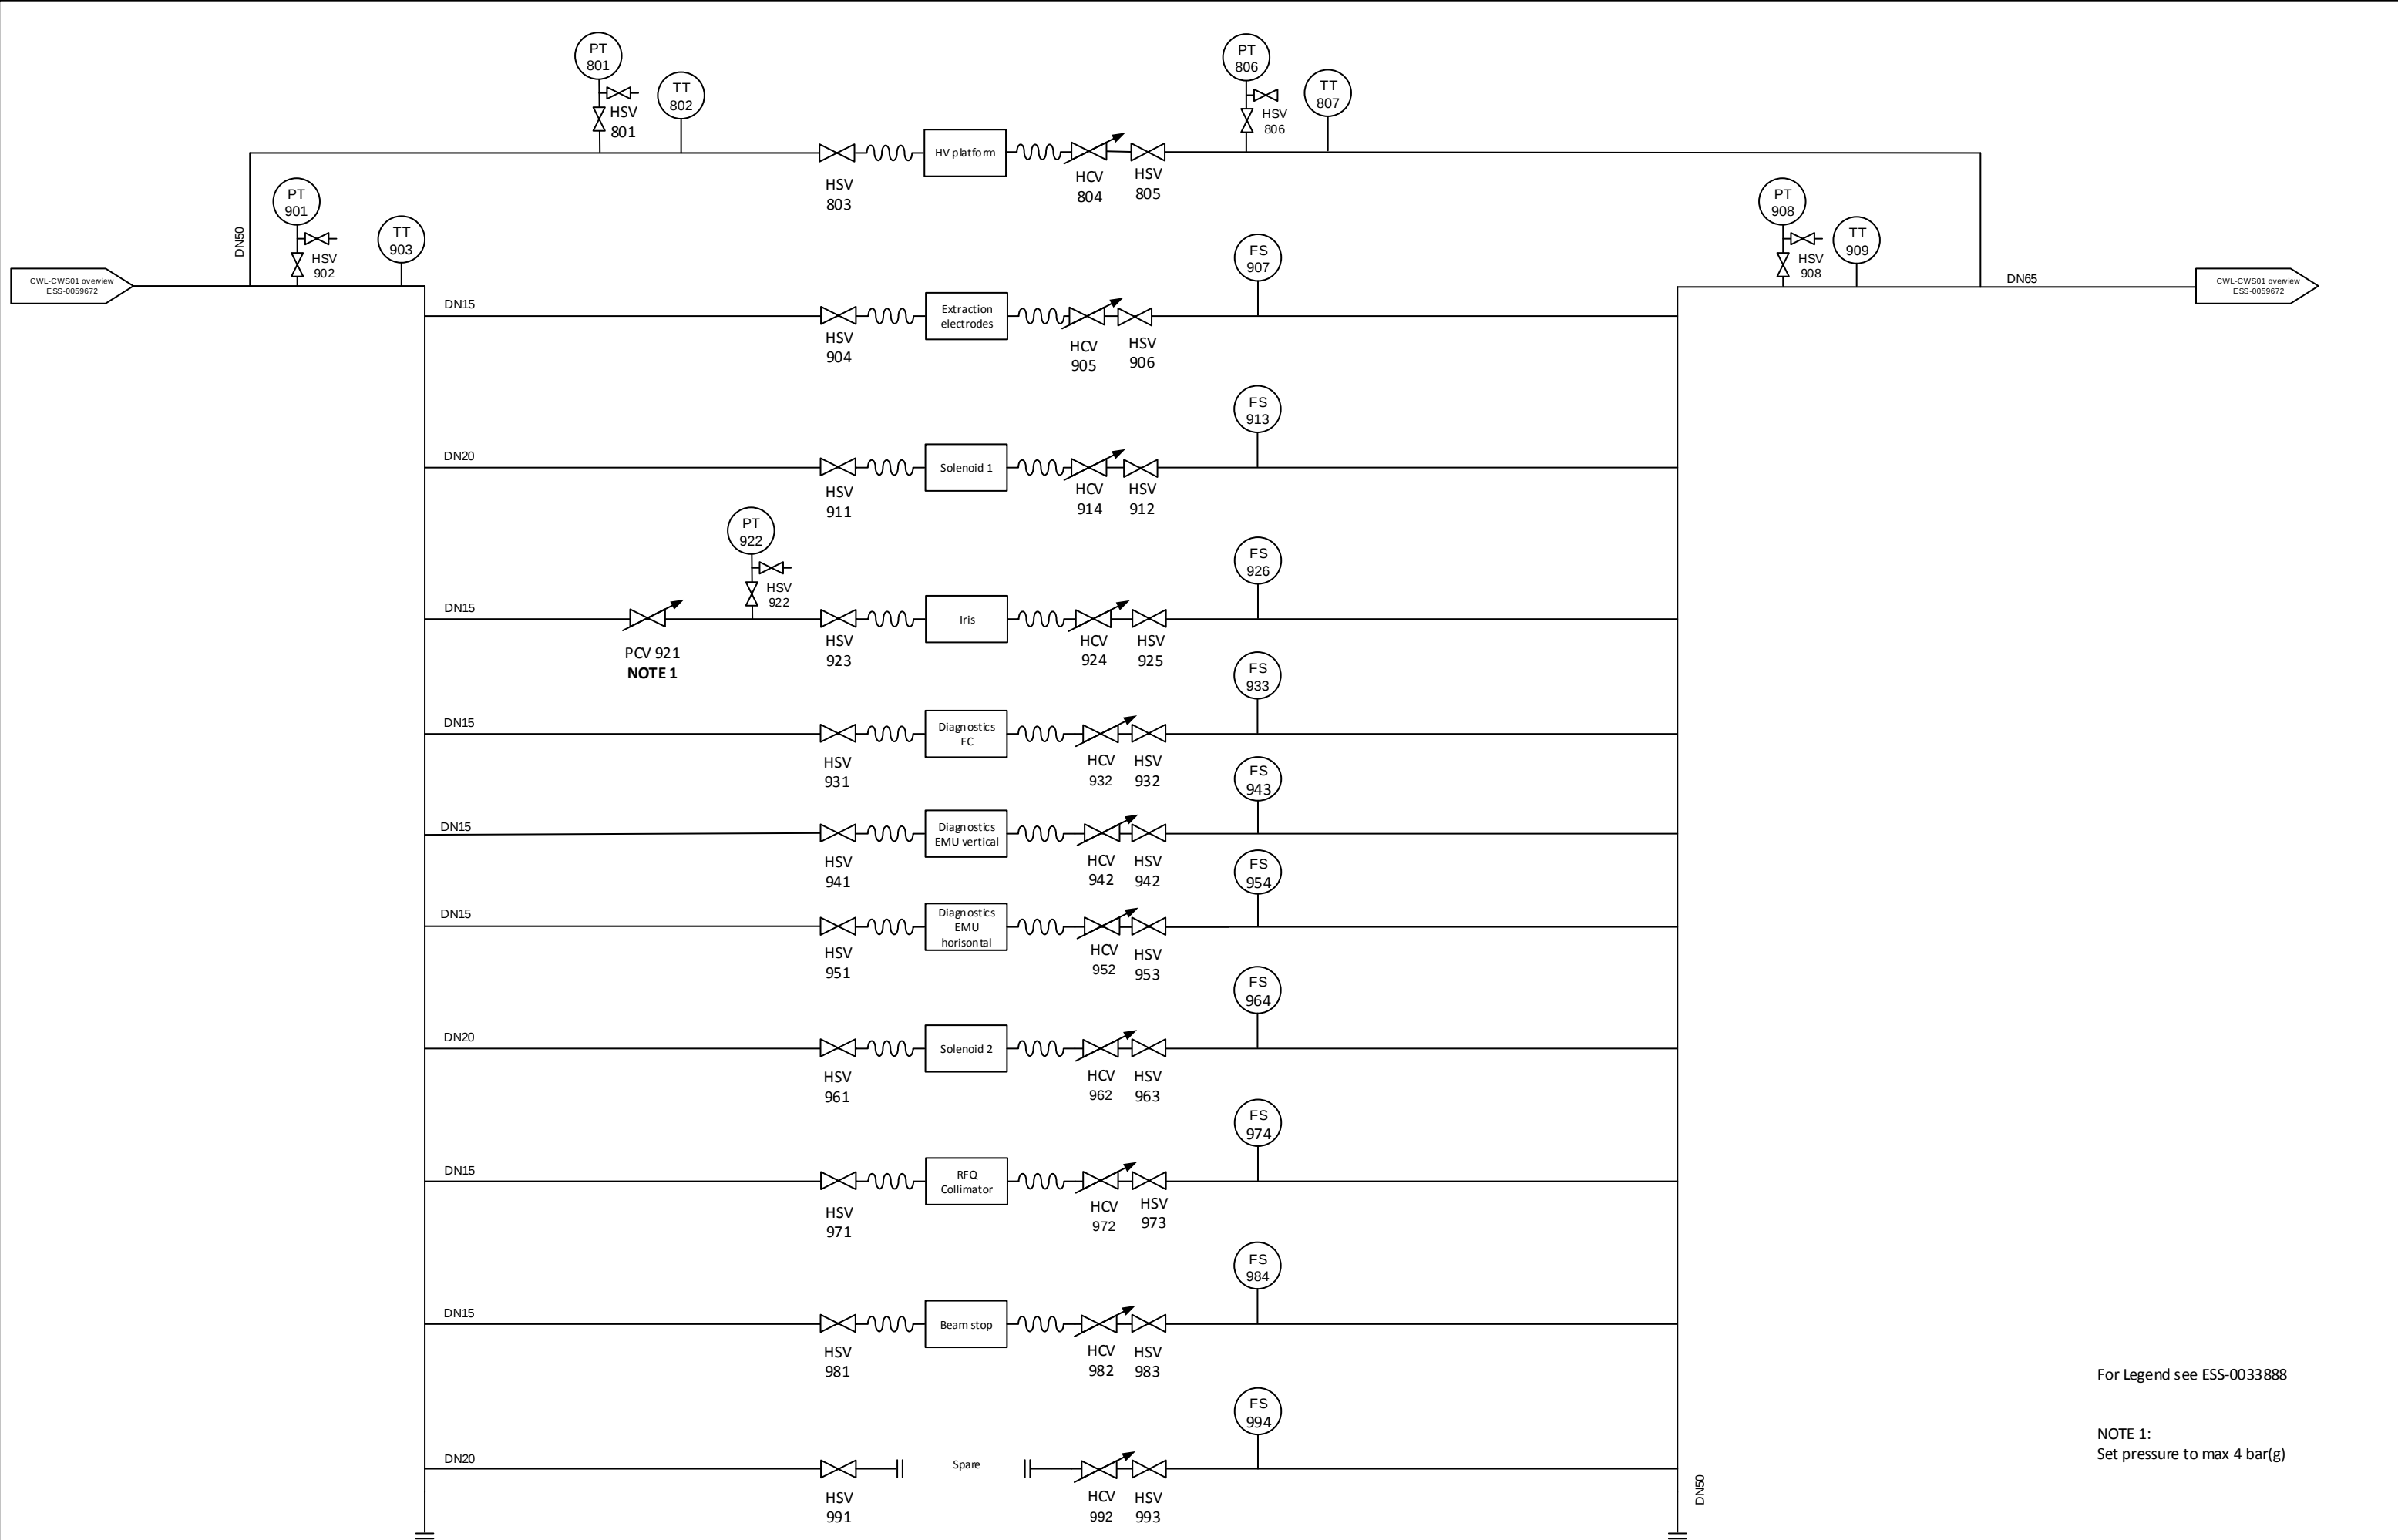

For Legend see ESS-0033888

NOTE 1:
Set pressure to max 4 bar(g)

Title IS and LEBT details		Approved by -	Signature	 EUROPEAN SPALLATION SOURCE
		Designed / changed by AC	Signature	
Type of drawing P&ID	Date (this version) 2016/10/01	Size A3	Scale -	Drawing No ESS-0059661
				Revision 1