



Title CWM-CWS02 overview		Approved by -		Signature	 EUROPEAN SPALLATION SOURCE
		Designed / changed by AC		Signature	
Type of drawing P&ID	Date (this version) 2016/10/07	Size A3	Page 1 of 5	Scale -	Drawing No ESS-0059673 Revision 1

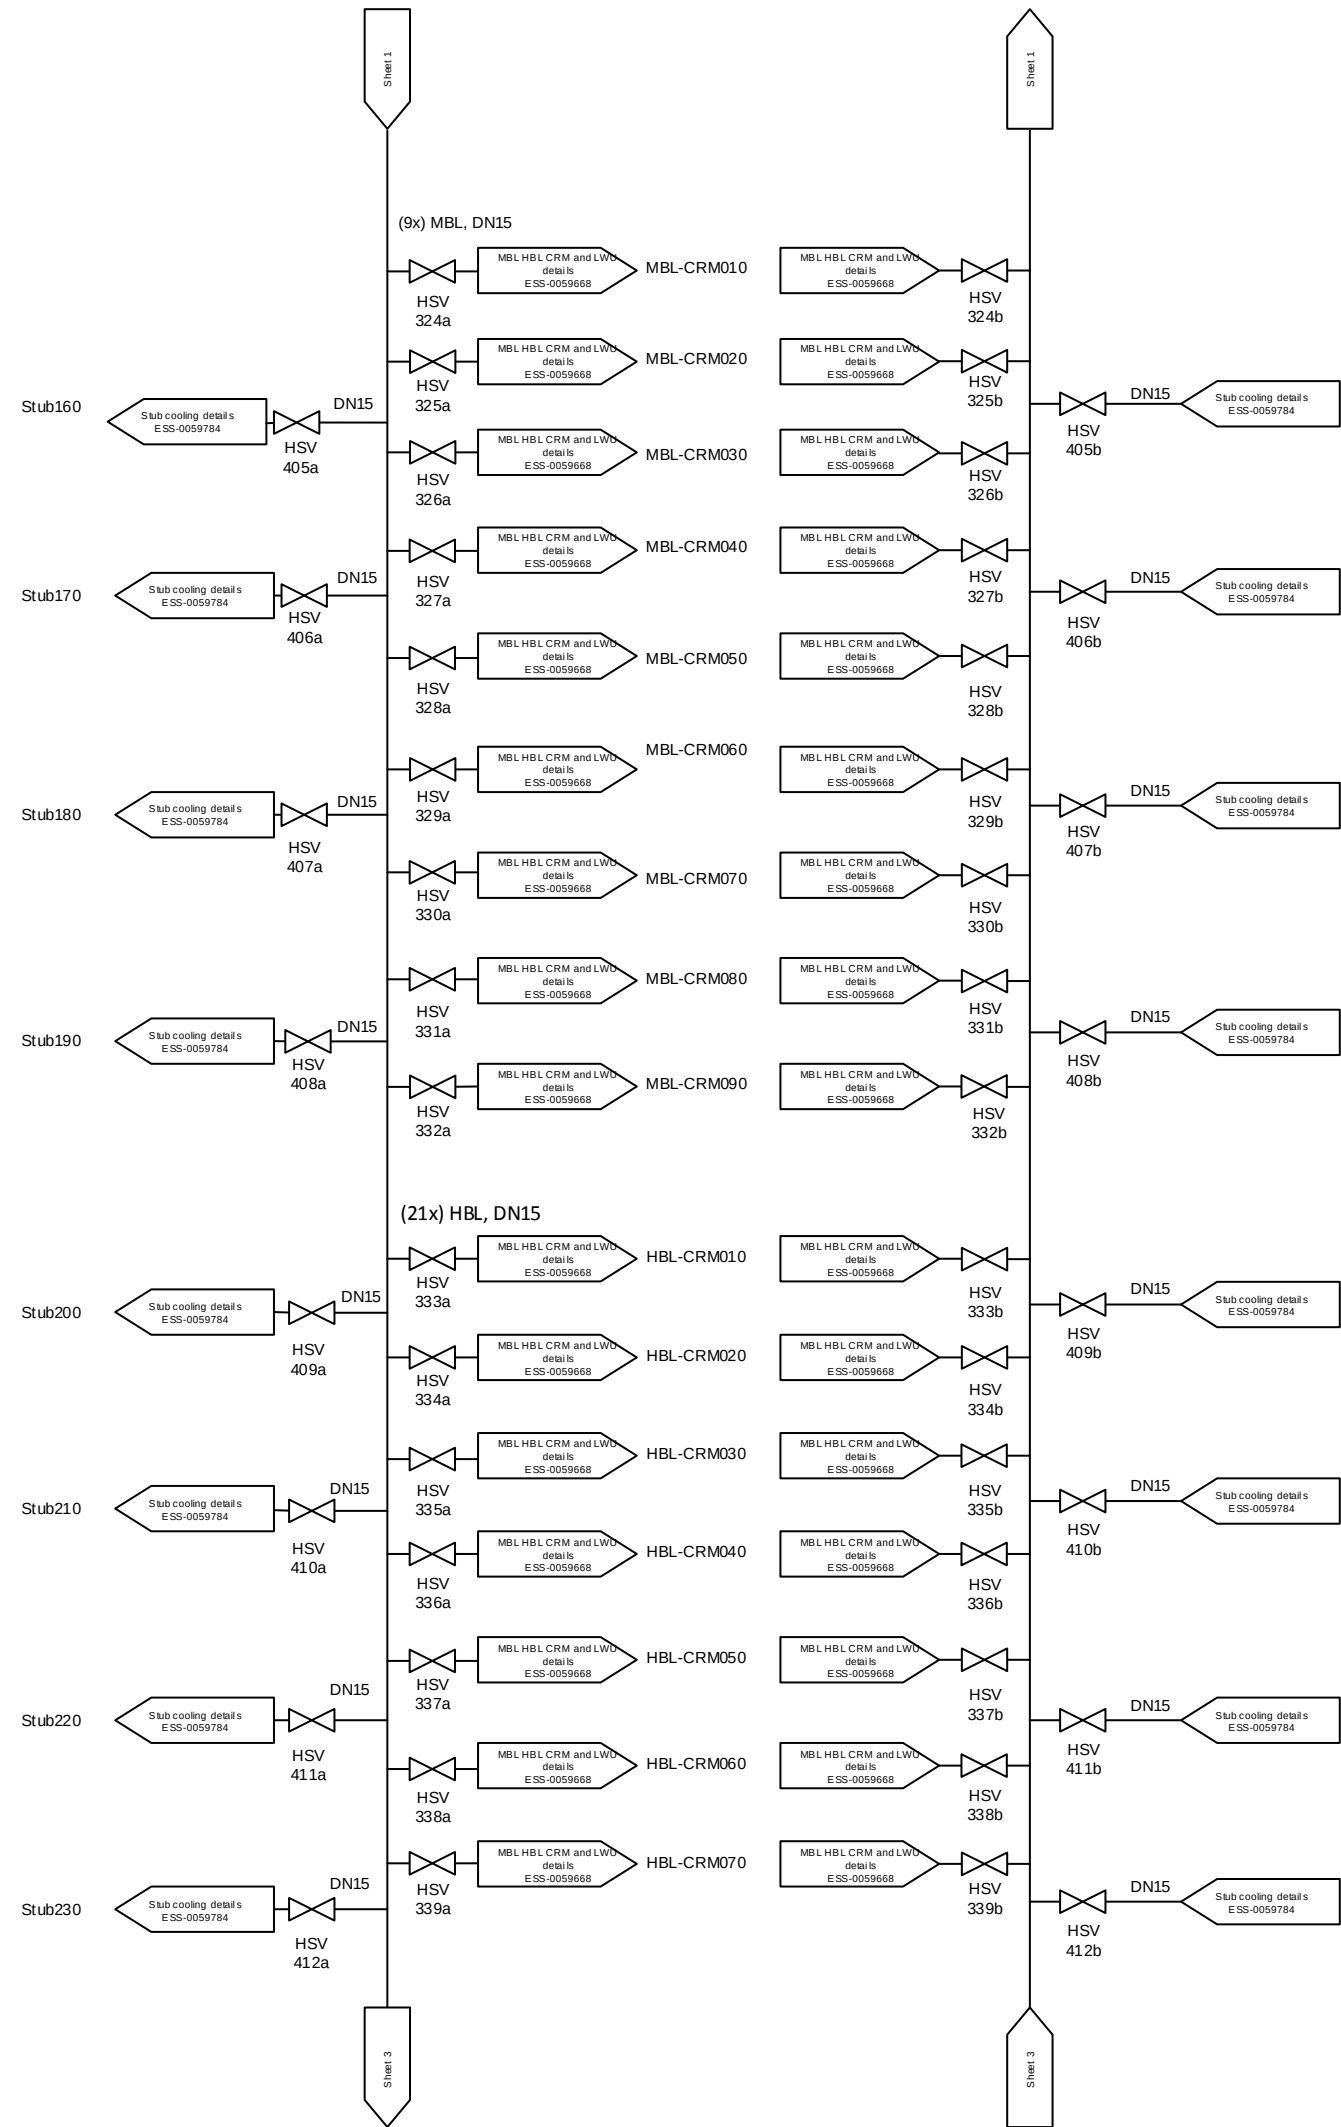

For Legend see ESS-0033888
Design pressure 10 bar(g)
Design temp Max/Min 50/10 °C


Title CWM-CWS02 overview		Approved by -		Signature	 EUROPEAN SPALLATION SOURCE
		Designed / changed by AC		Signature	
Type of drawing P&ID	Date (this version) 2016/10/07	Size A3	Page 2 of 5	Scale -	Drawing No ESS-0059673 Revision 1

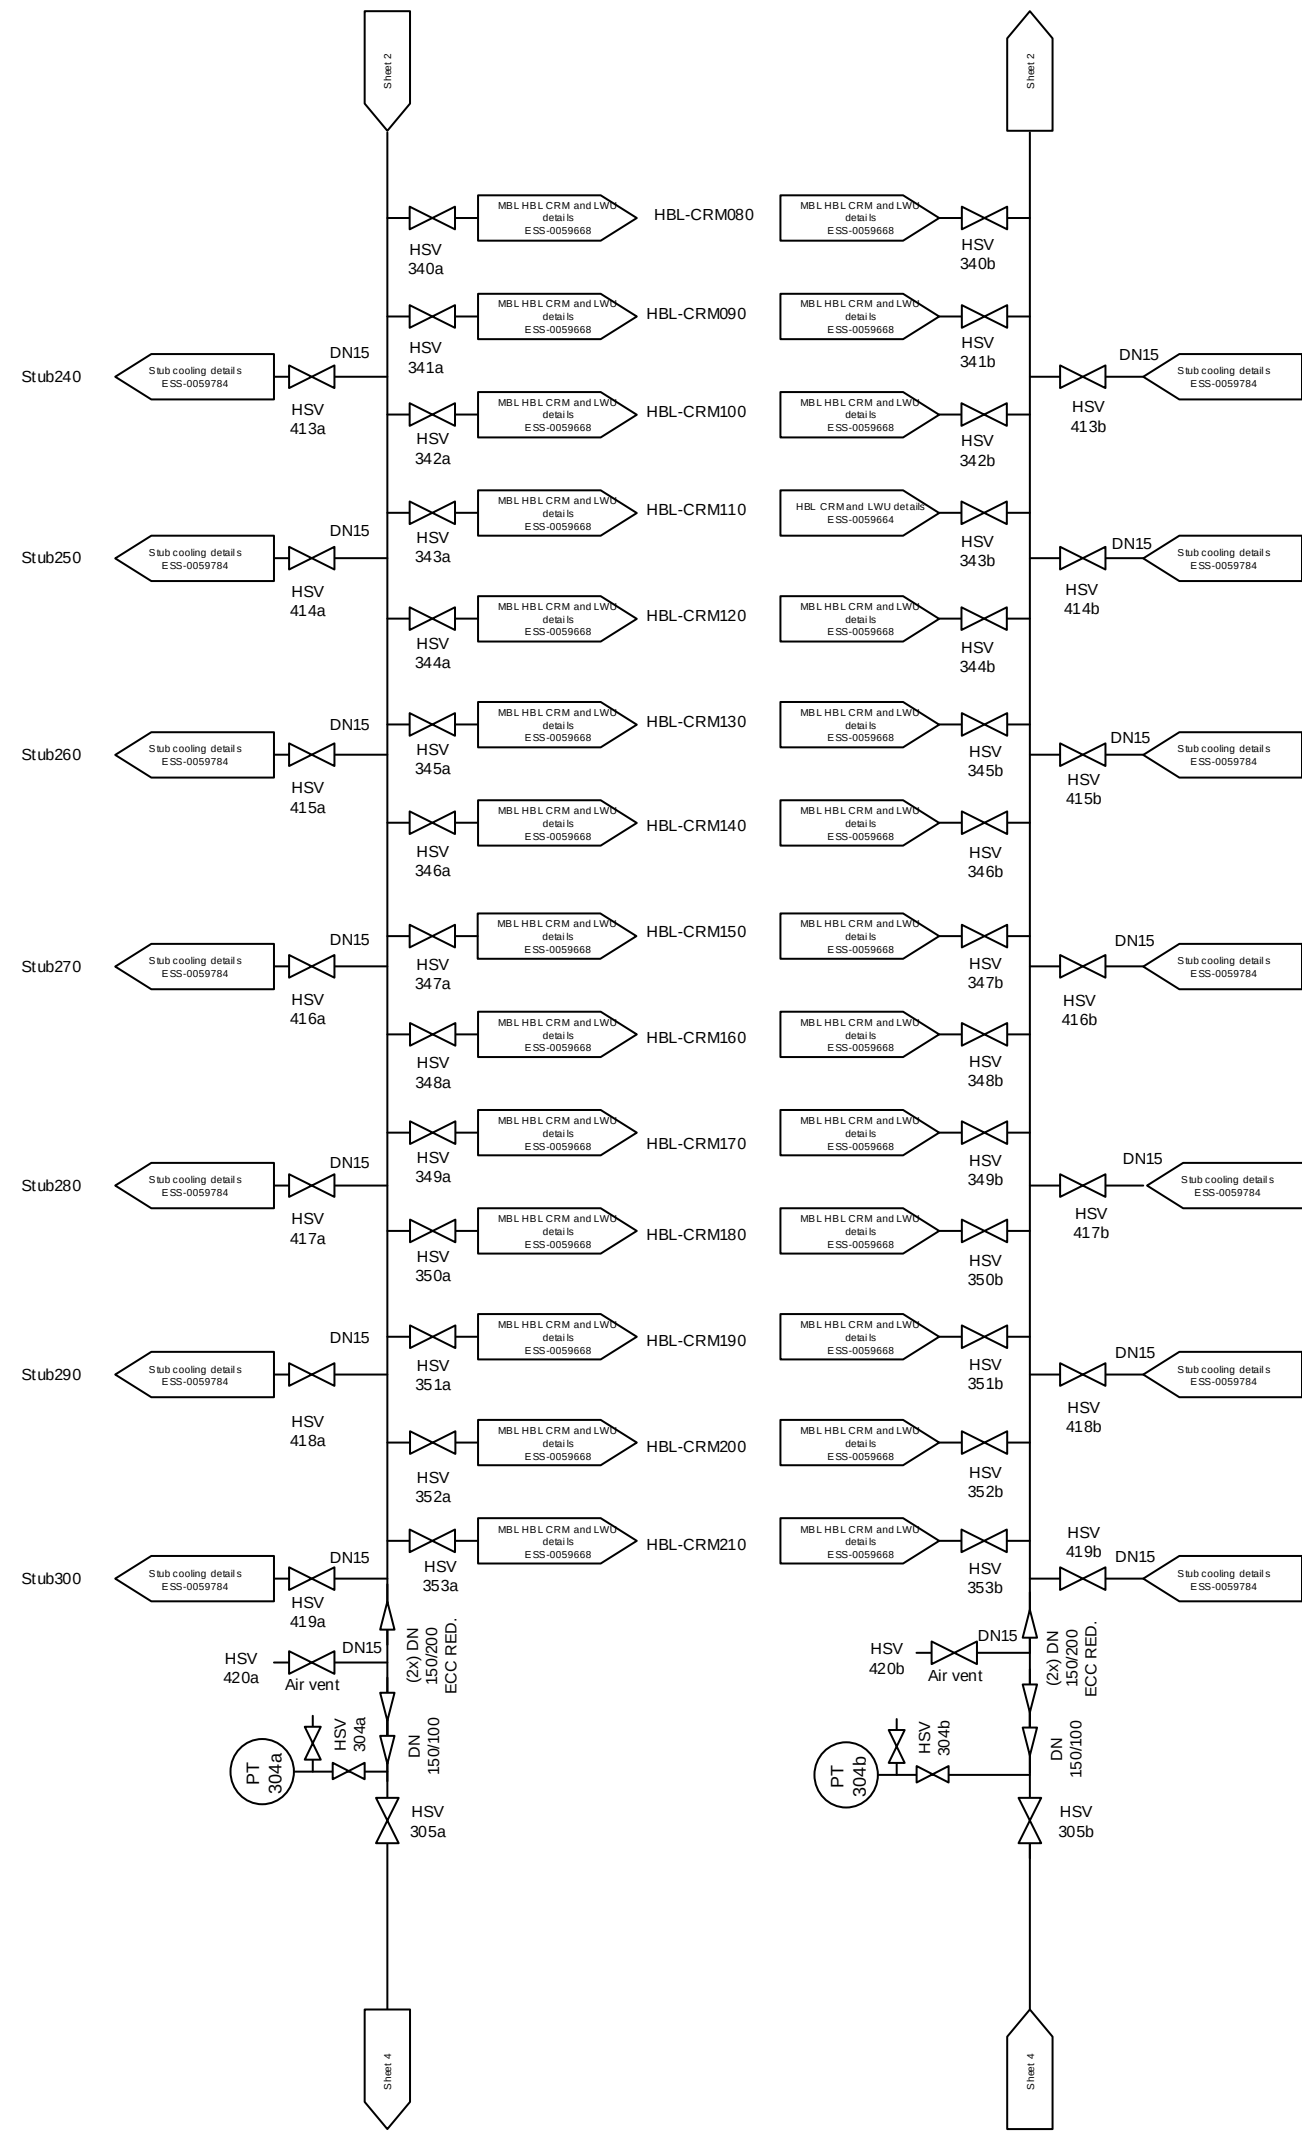

For Legend see ESS-0033888
Design pressure 10 bar(g)
Design temp Max/Min 50/10 °C


Title CWM-CWS02 overview		Approved by -		Signature	
		Designed / changed by AC		Signature	
Type of drawing P&ID	Date (this version) 2016/10/07	Size A3	Page 3 of 5	Scale -	Drawing No ESS-0059673 Revision 1



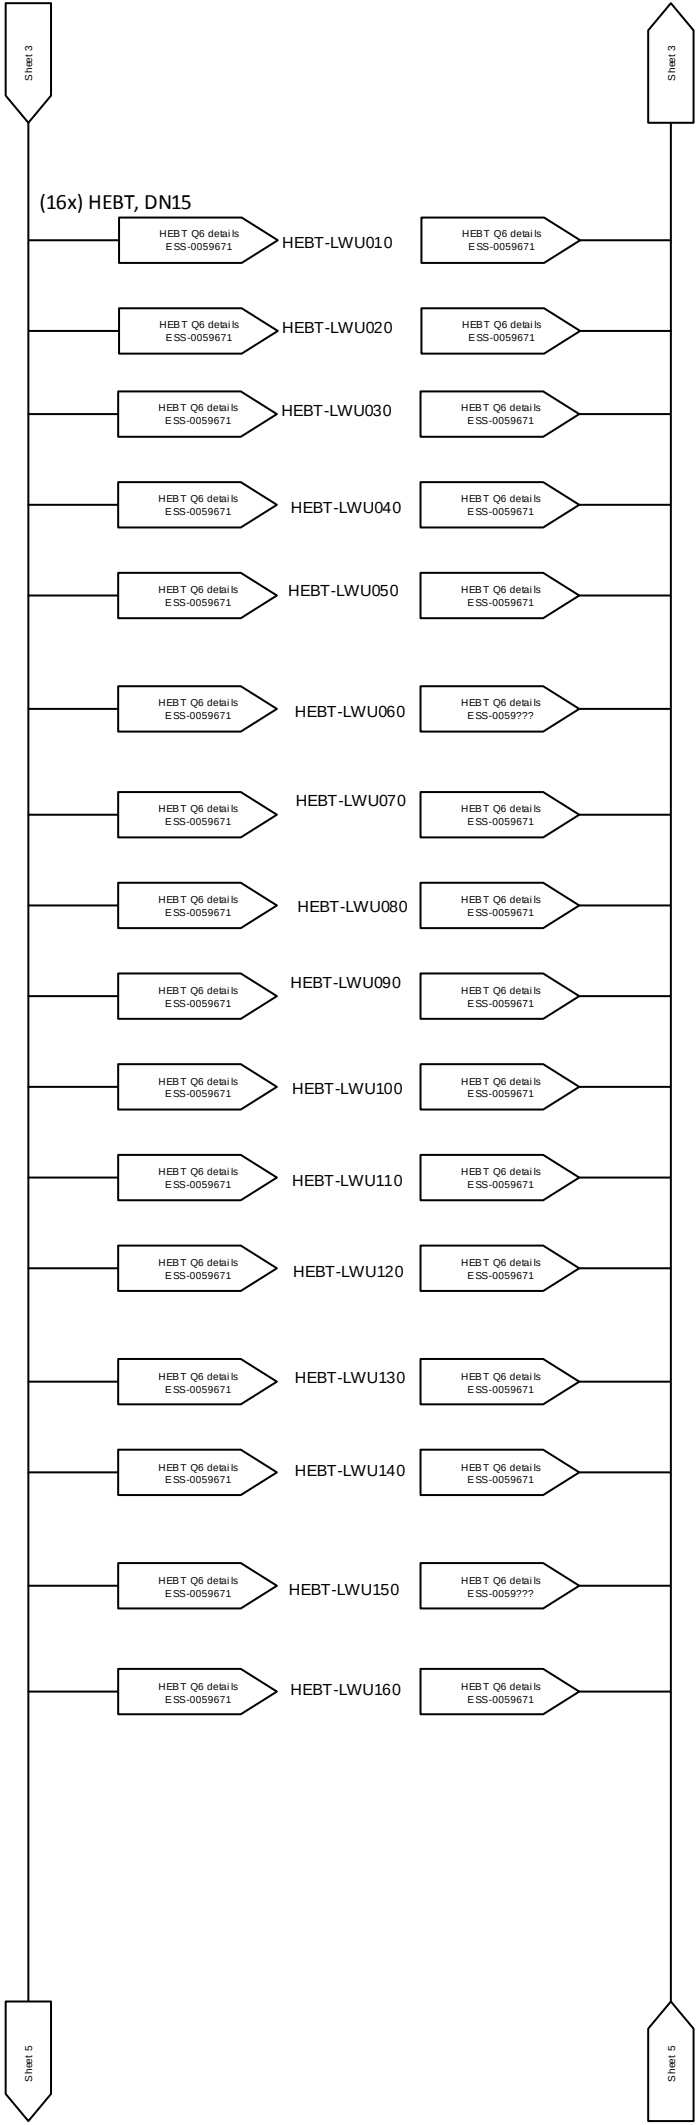

For Legend see ESS-0033888
Design pressure 10 bar(g)
Design temp Max/Min 50/10 °C

Title CWM-CWS02 overview		Approved by -		Signature	 EUROPEAN SPALLATION SOURCE
		Designed / changed by AC		Signature	
Type of drawing P&ID	Date (this version) 2016/10/07	Size A3	Page 4 of 5	Scale -	Drawing No ESS-0059673 Revision 1

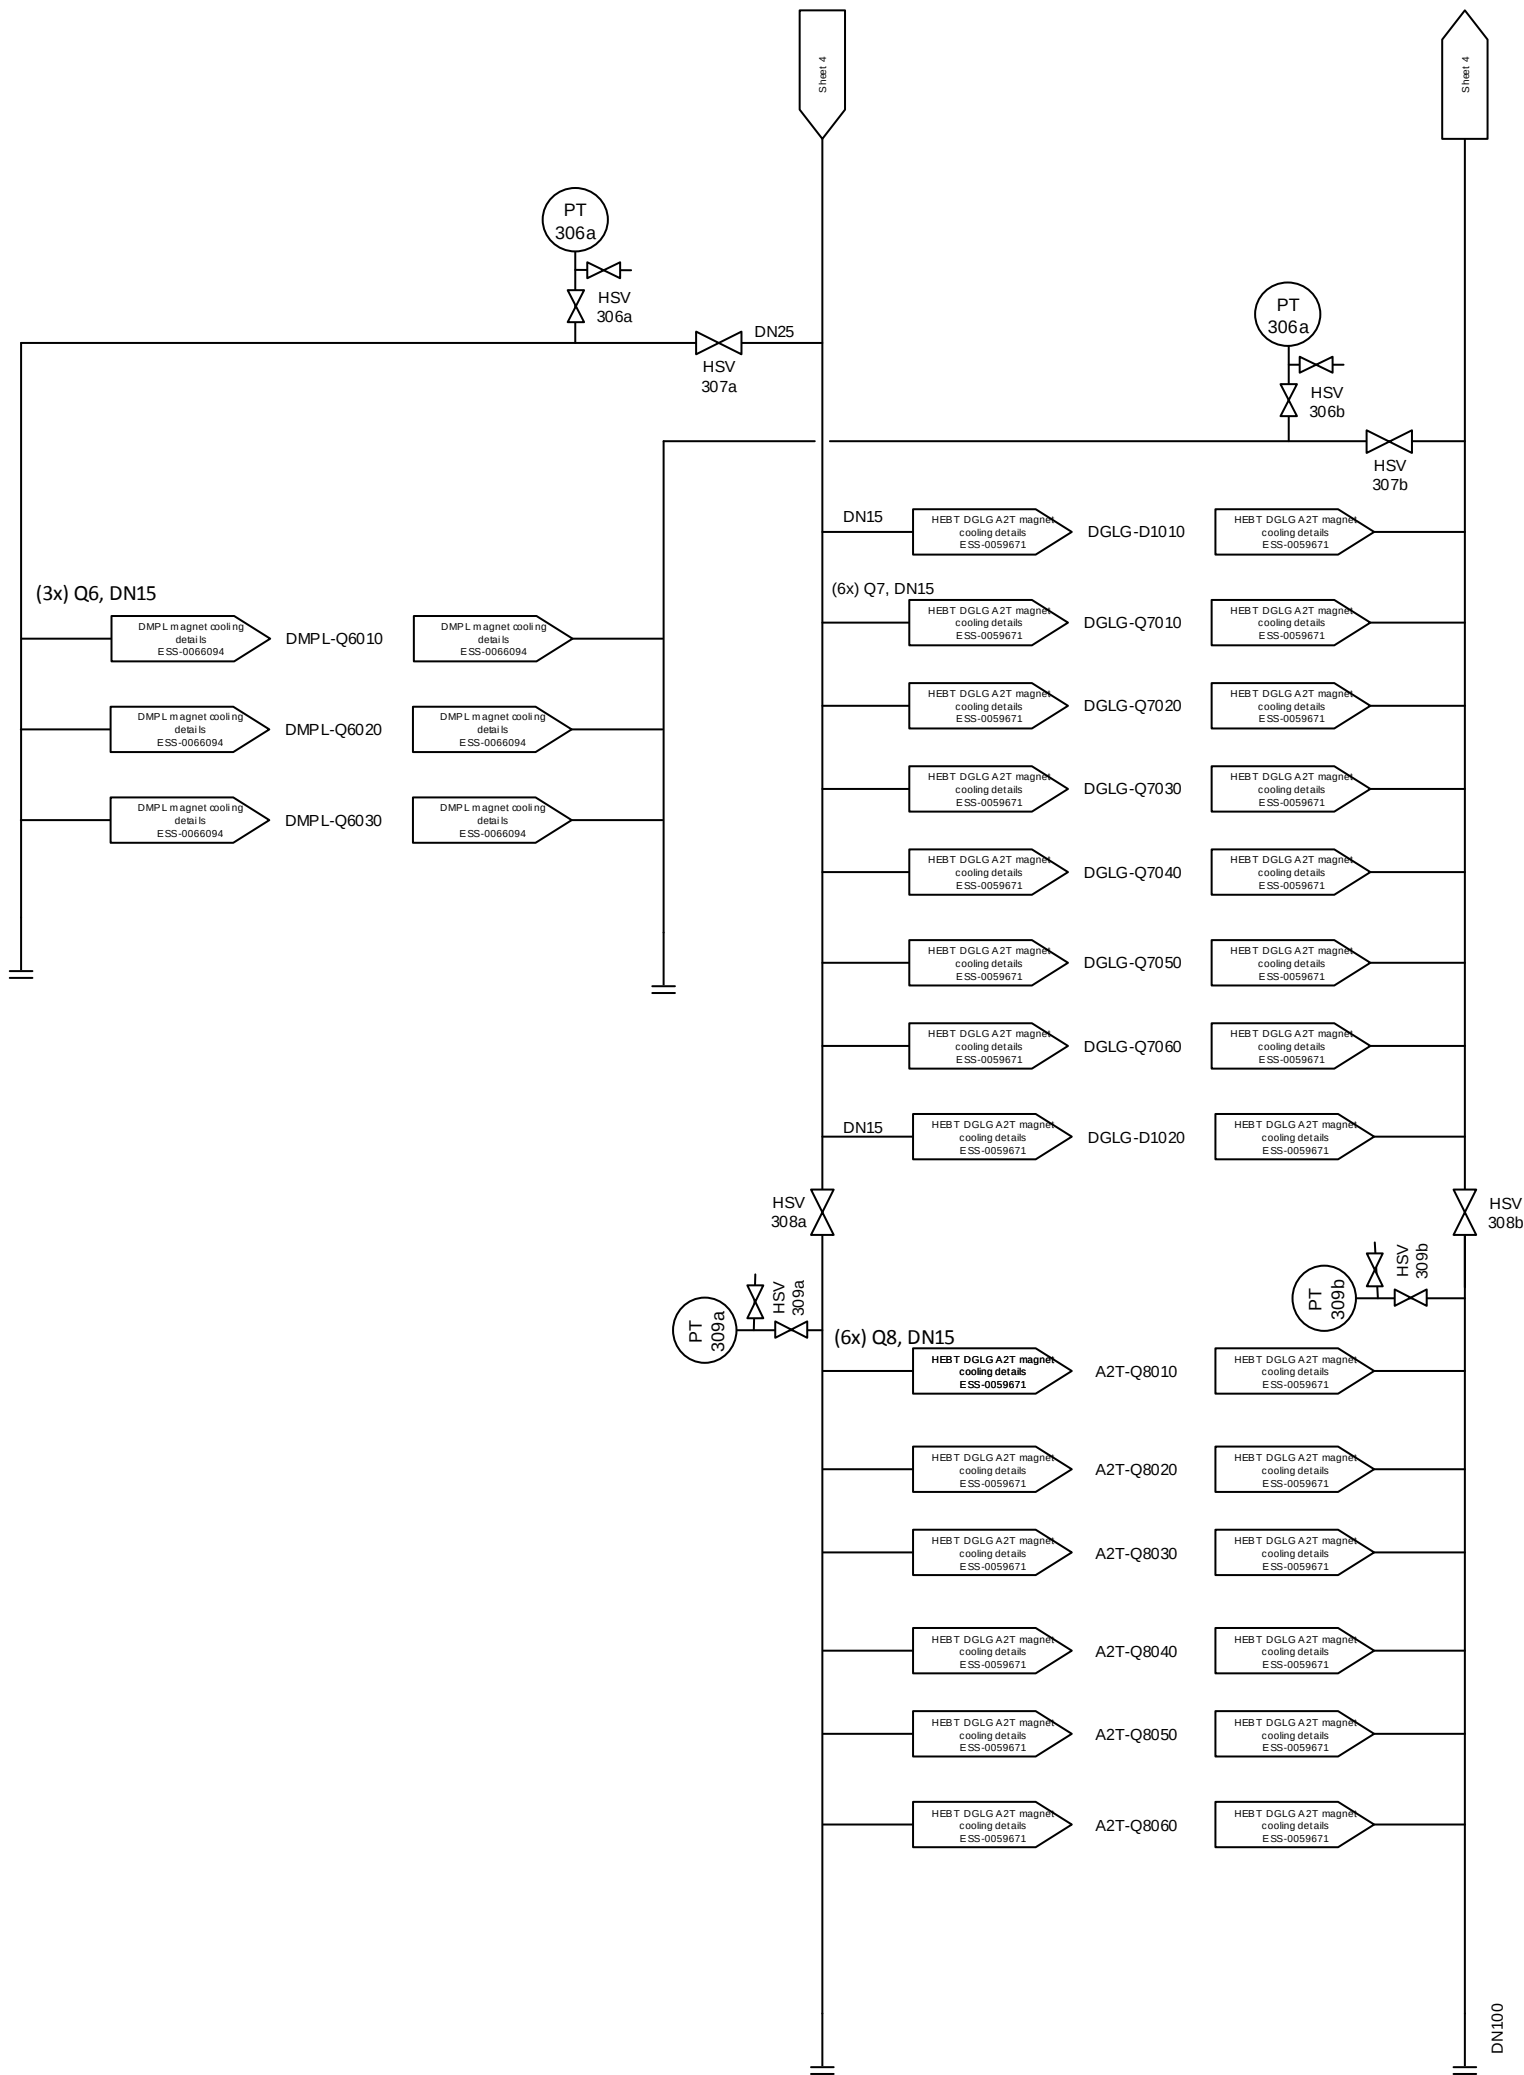

For Legend see ESS-0033888
Design pressure 10 bar(g)
Design temp Max/Min 50/10 °C

Title CWM-CWS02 overview		Approved by -		Signature	 EUROPEAN SPALLATION SOURCE
		Designed / changed by AC		Signature	
Type of drawing P&ID	Date (this version) 2016/10/07	Size A3	Page 5 of 5	Scale -	Drawing No ESS-0059673 Revision 1