


Title CWL-CWS01 overview ESS.ACC.E02.E01		Approved by -		Signature	 EUROPEAN SPALLATION SOURCE
		Designed / changed by AC		Signature	
Type of drawing P&ID	Date (this version) 2017/04/20	Size A3	Page 1 of 2	Scale -	Drawing No ESS-0059672 Revision 1.2



- Notes:
1. For Legend see ESS-0033888.
 2. Magnet (QUAD Q1 - QUAD Q11) hoses to be of non conducting hose material.
 3. Instrument transmitters to be protected from radiation.
 4. Threaded instrument connection point, G ½".
 5. Add blind flange for every battery limit.

6. Tender battery delimiter

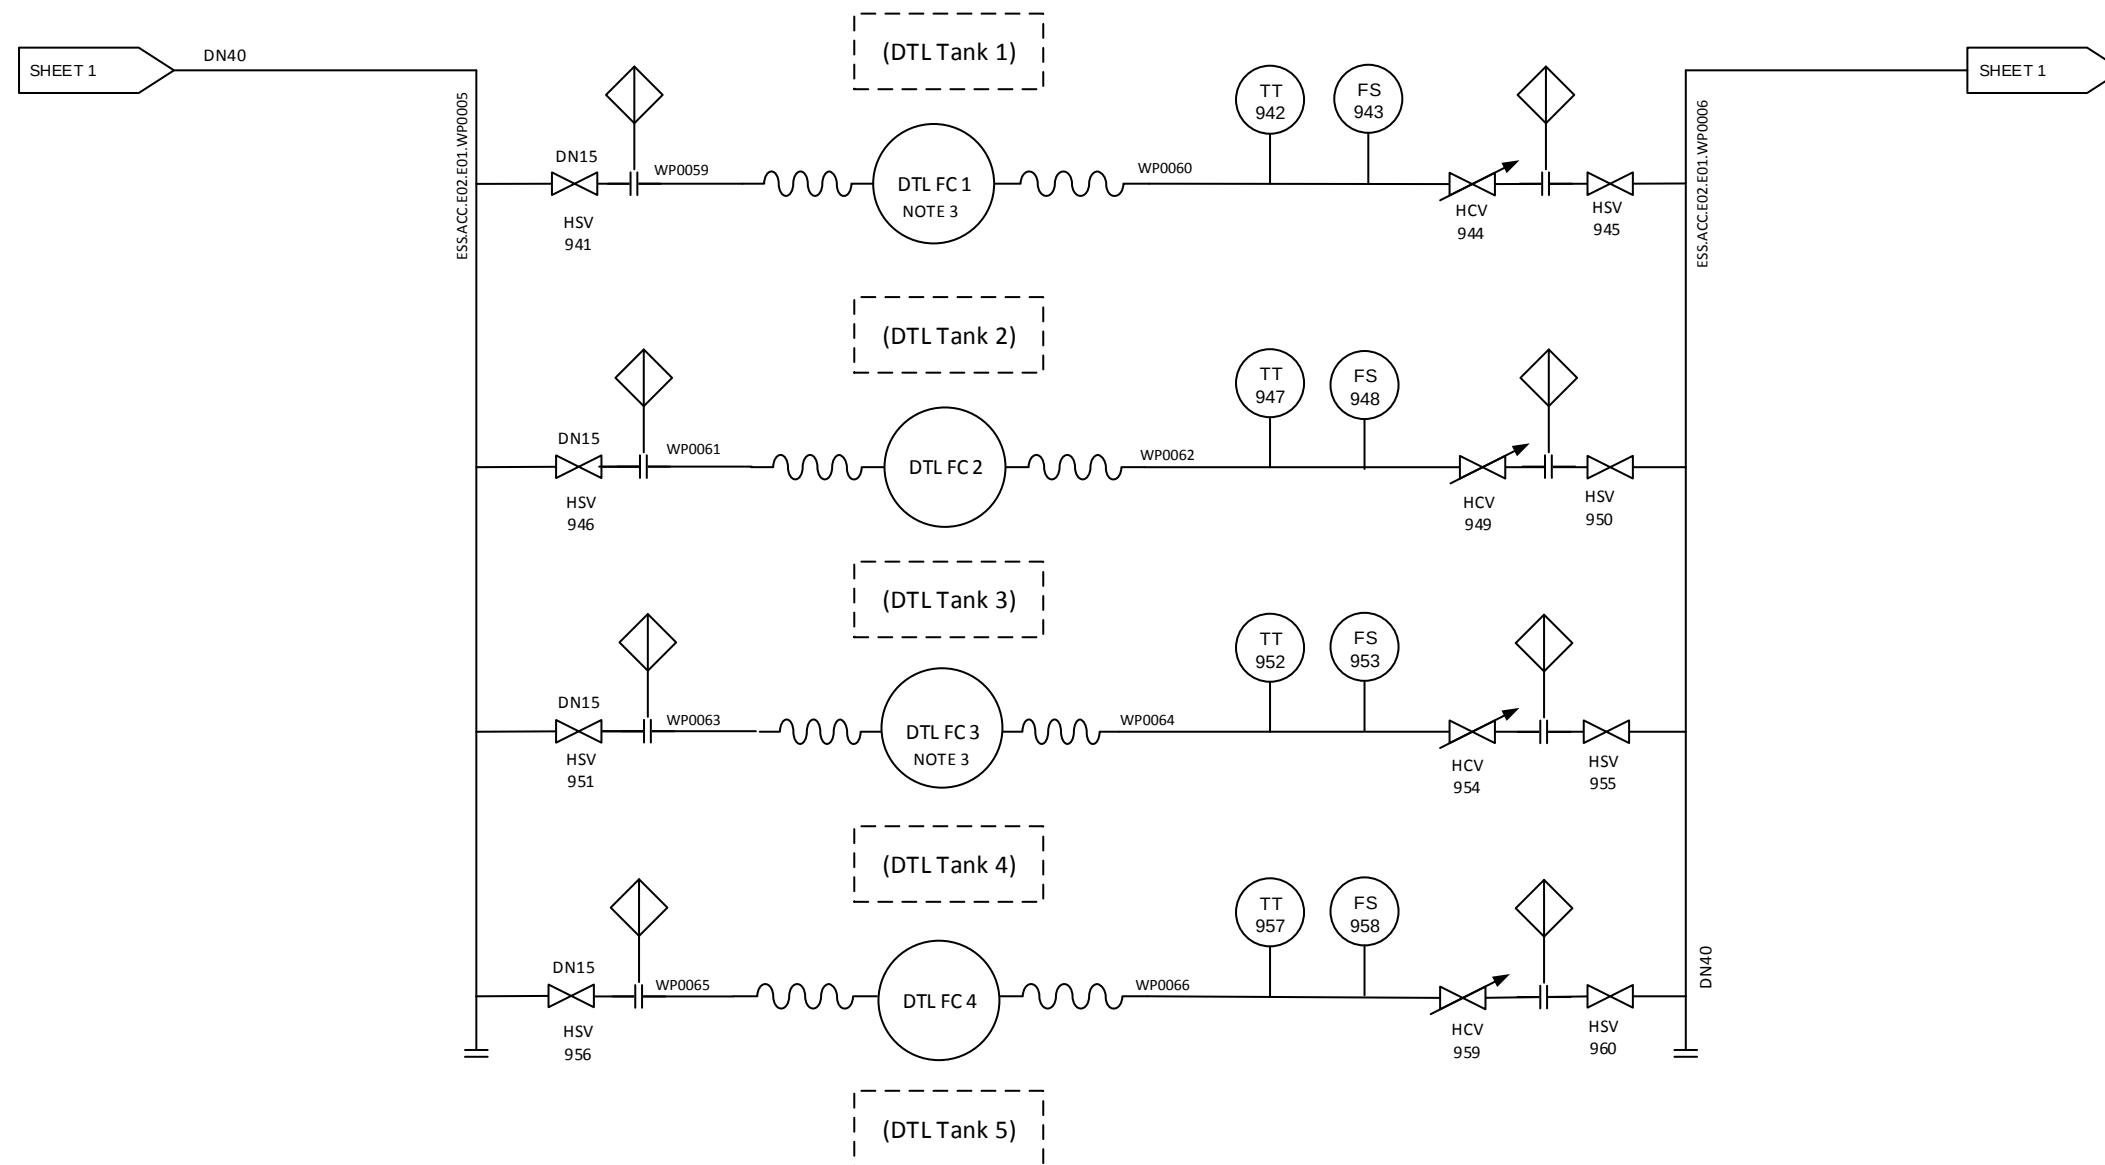

Title CWL-CWS01 overview ESS.ACC.E02.E01		Approved by -		Signature	
		Designed / changed by AC		Signature	
Type of drawing P&ID	Date (this version) 2017/04/20	Size A3	Page 2 of 2	Scale -	Drawing No ESS-0059672
				Revision 1.2	

